




4 MEZZANINE LEVEL PROPOSED: ELECTRICAL  
2.1 Scale: 1/4" = 1'-0"

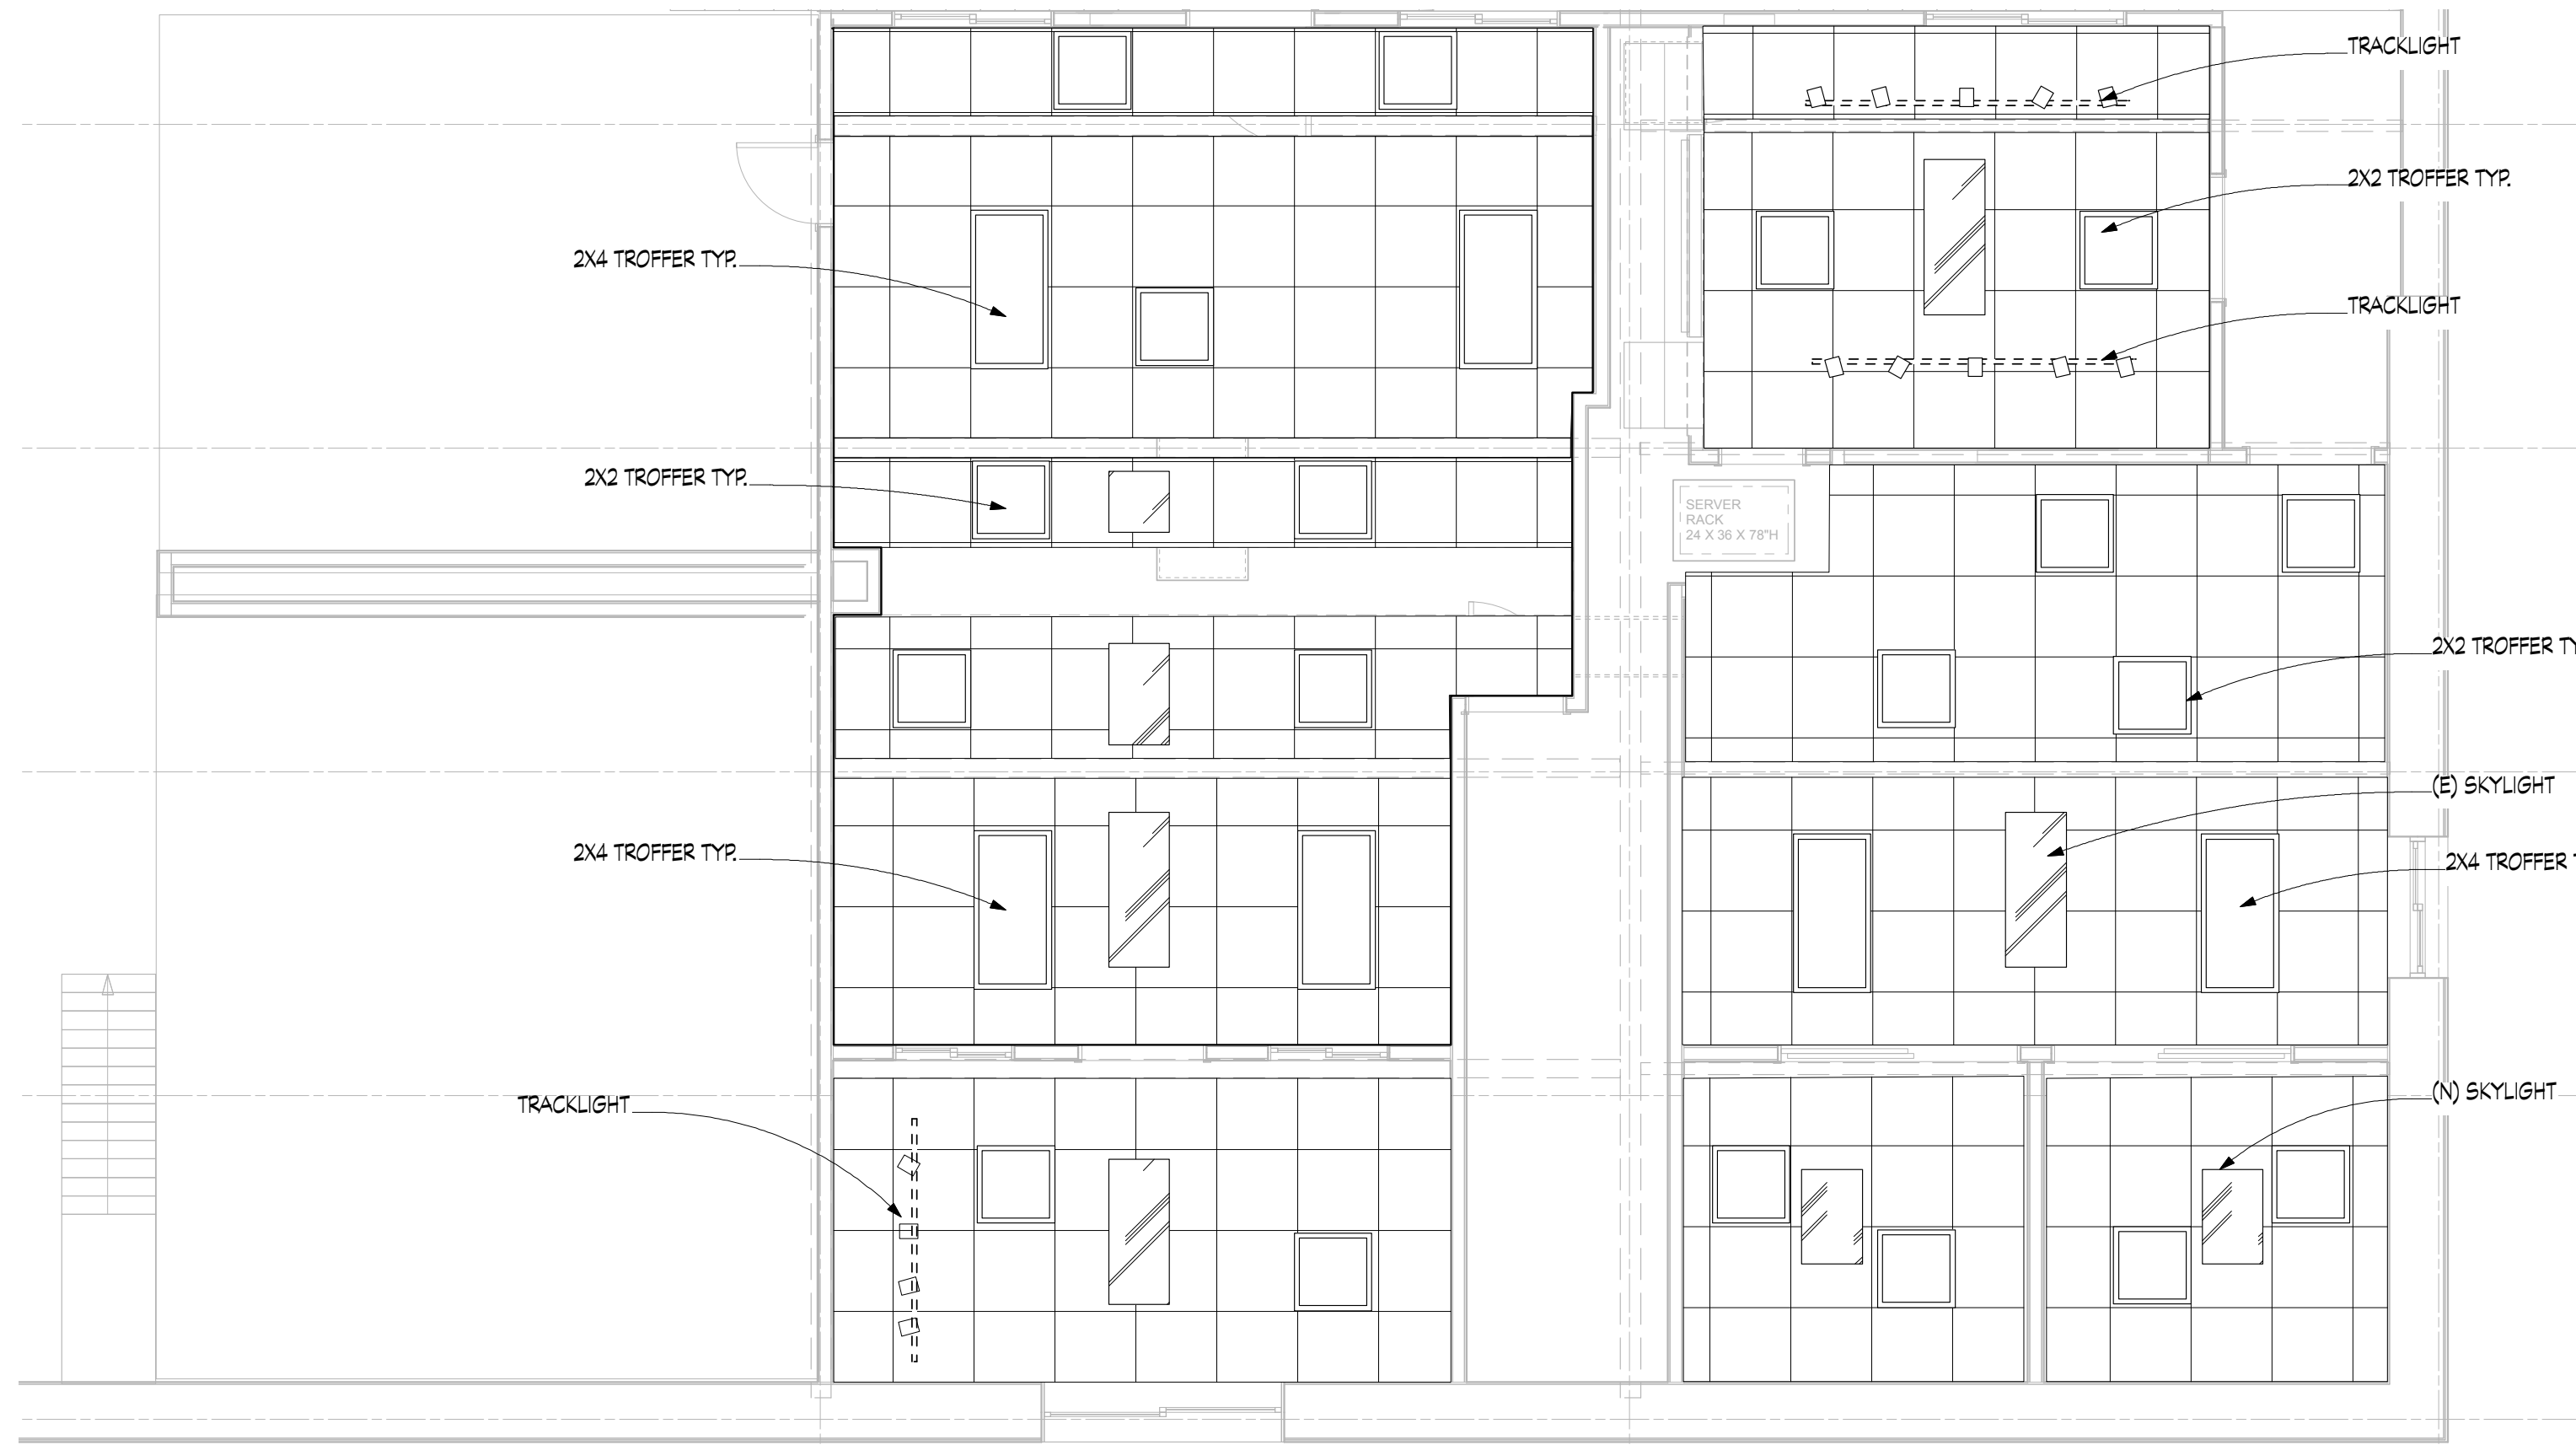

2 MEZZANINE LEVEL PROPOSED: RCP & LIGHTING  
2.1 Scale: 1/4" = 1'-0"

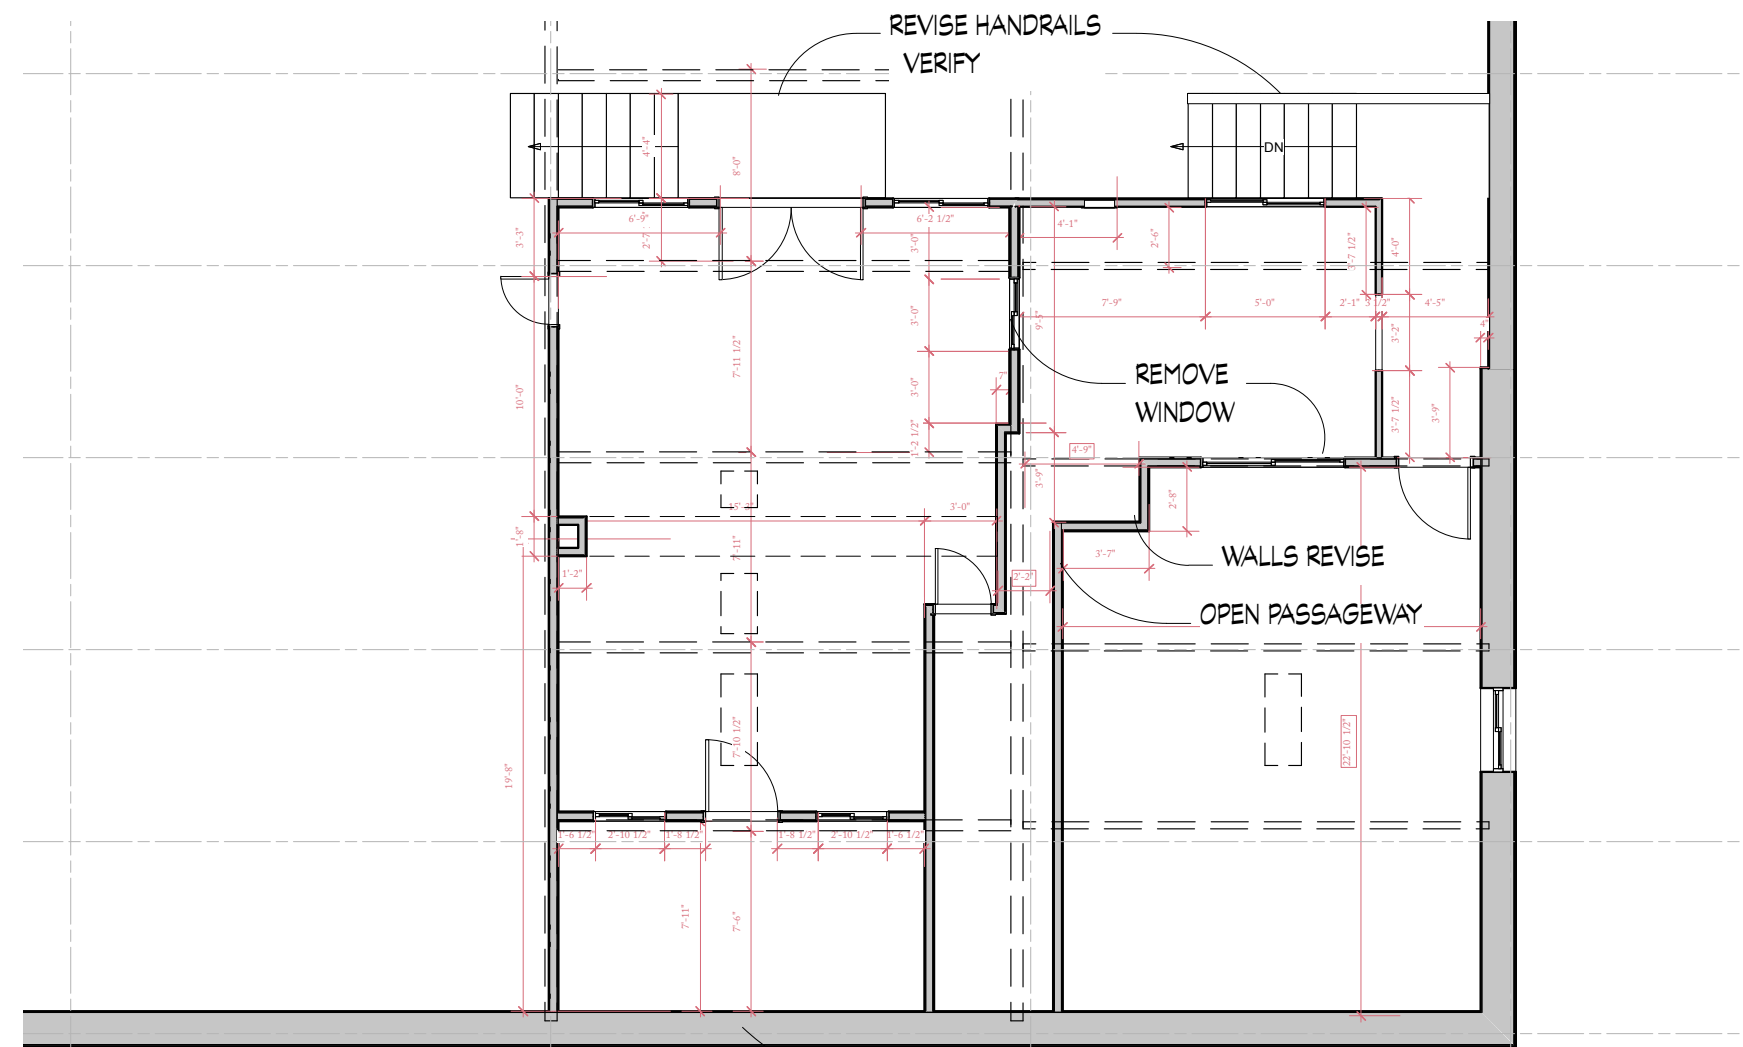

3 UPPER LEVEL EXISTING, DEMOLITION PLAN  
2.1 Scale: 1/8" = 1'-0"

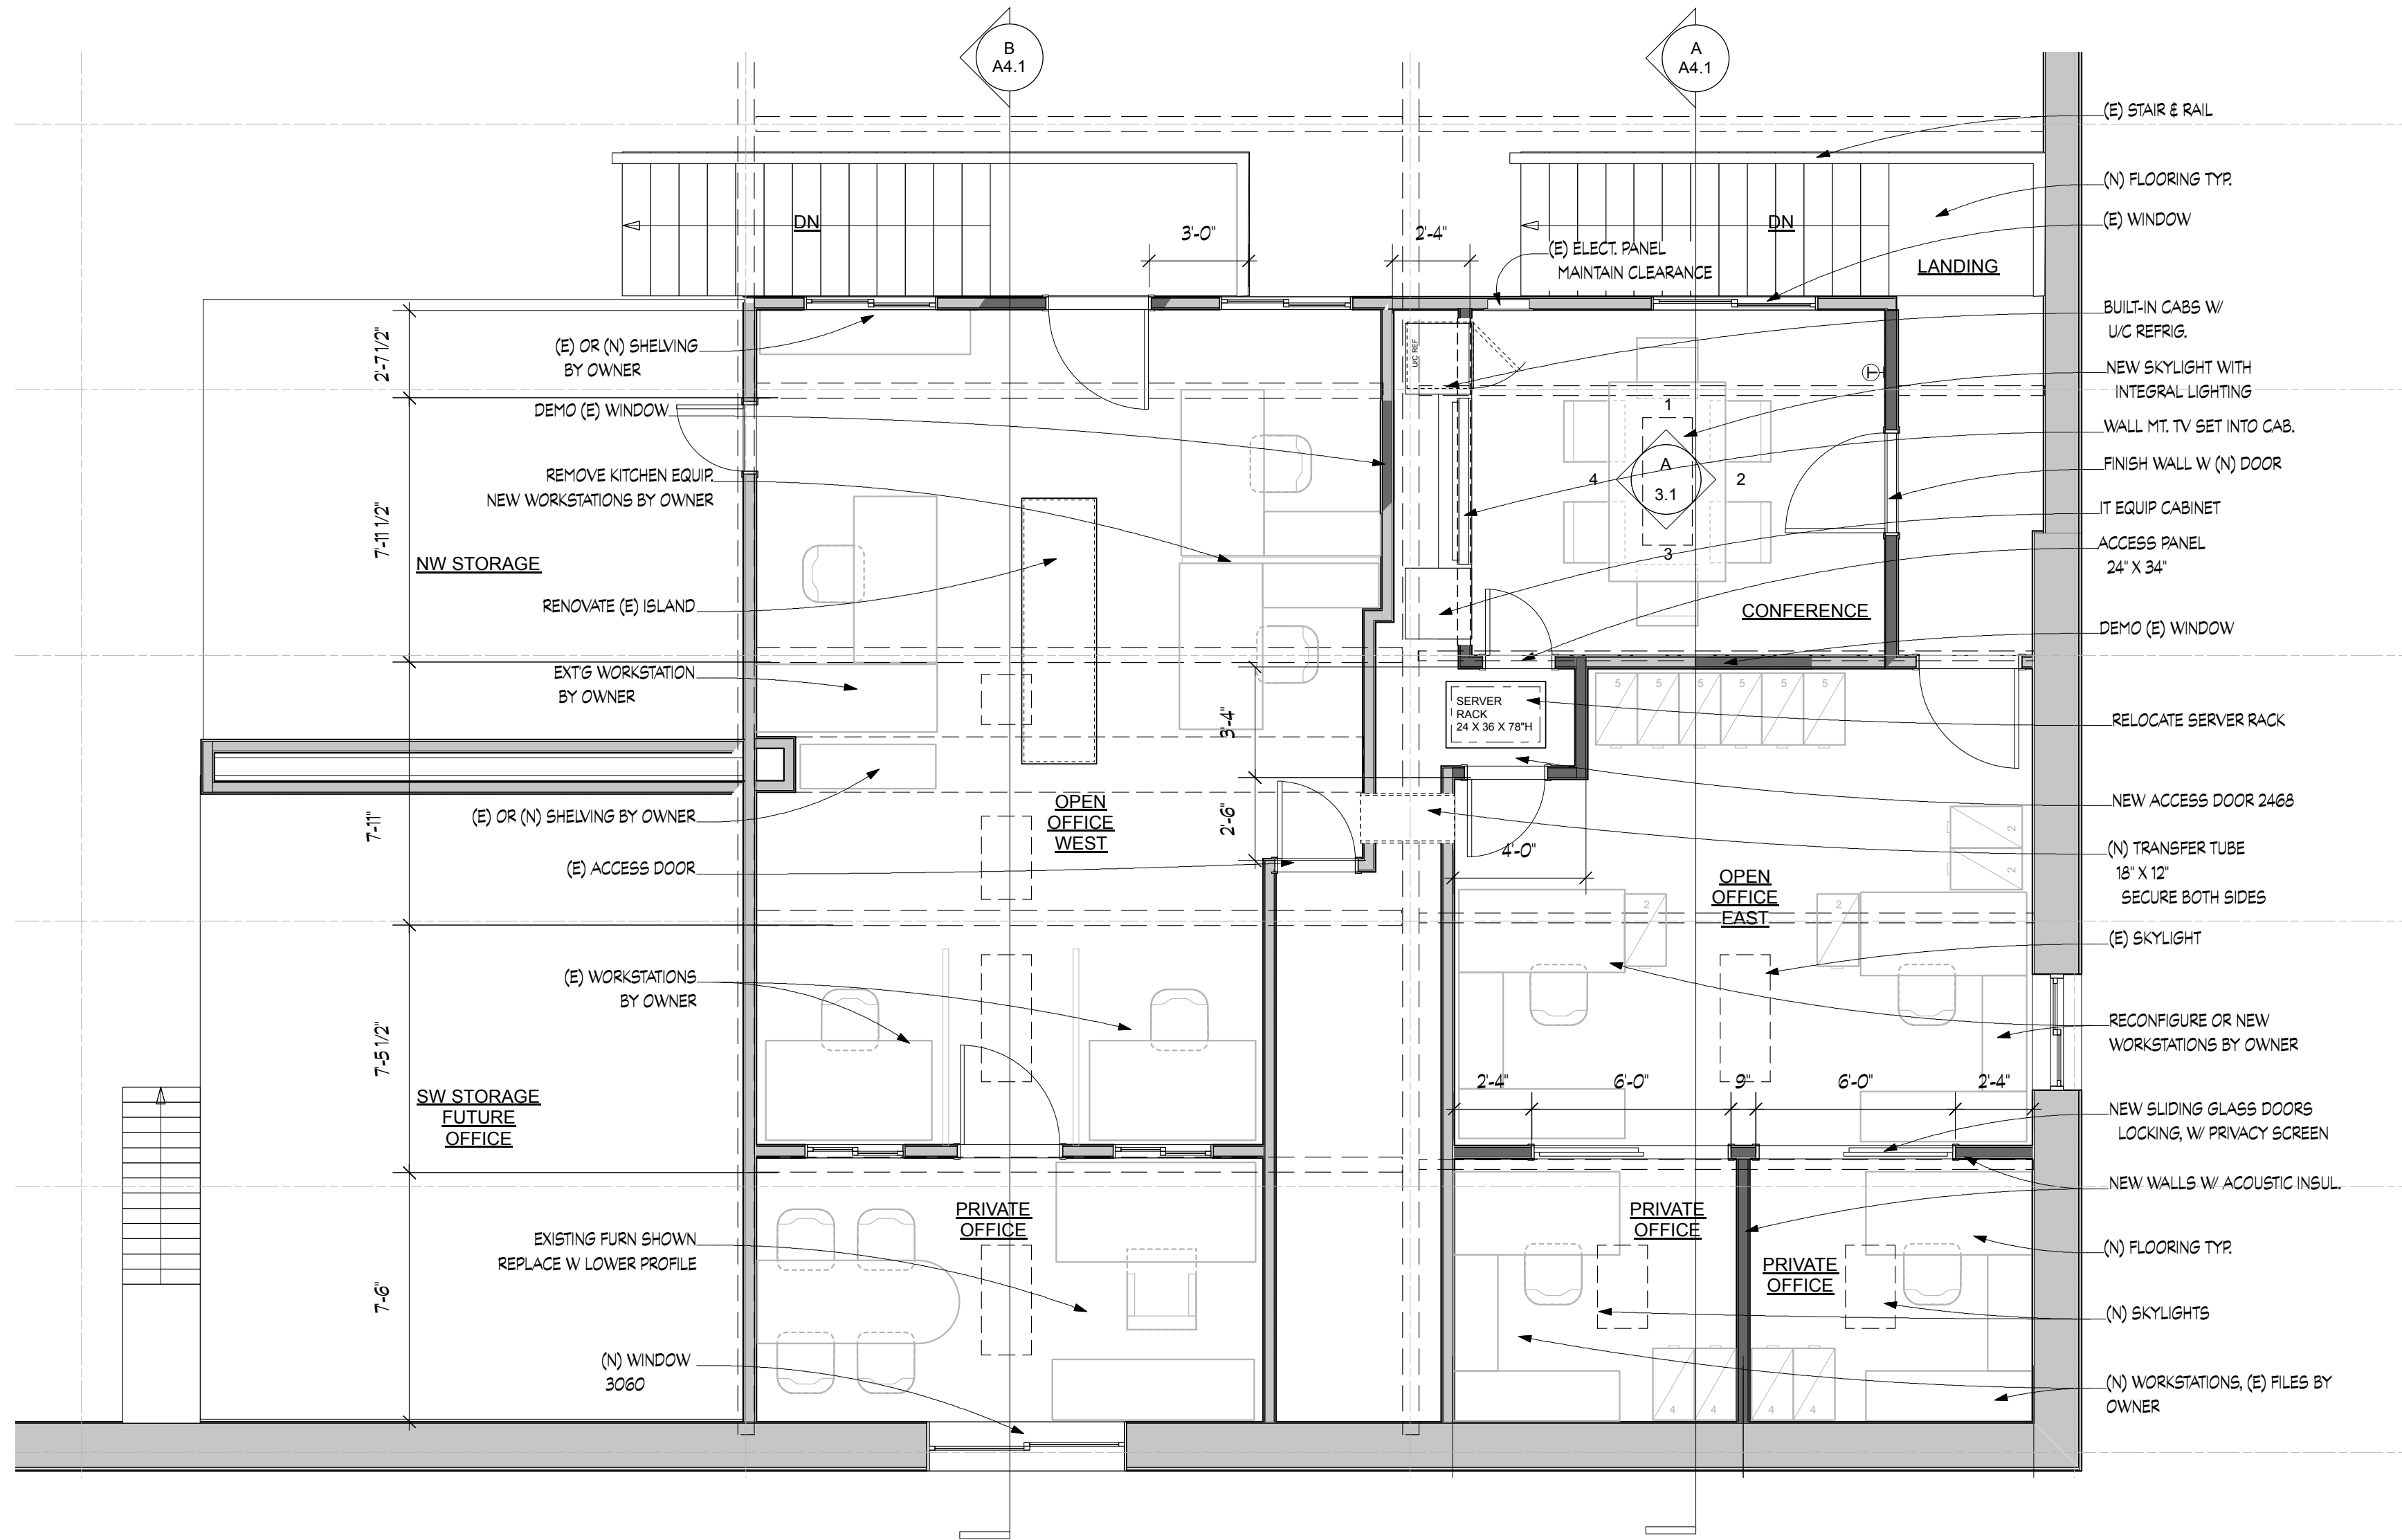

1 MEZZANINE LEVEL PROPOSED: CONSTRUCTION FLOOR PLAN  
2.1 Scale: 1/4" = 1'-0"